
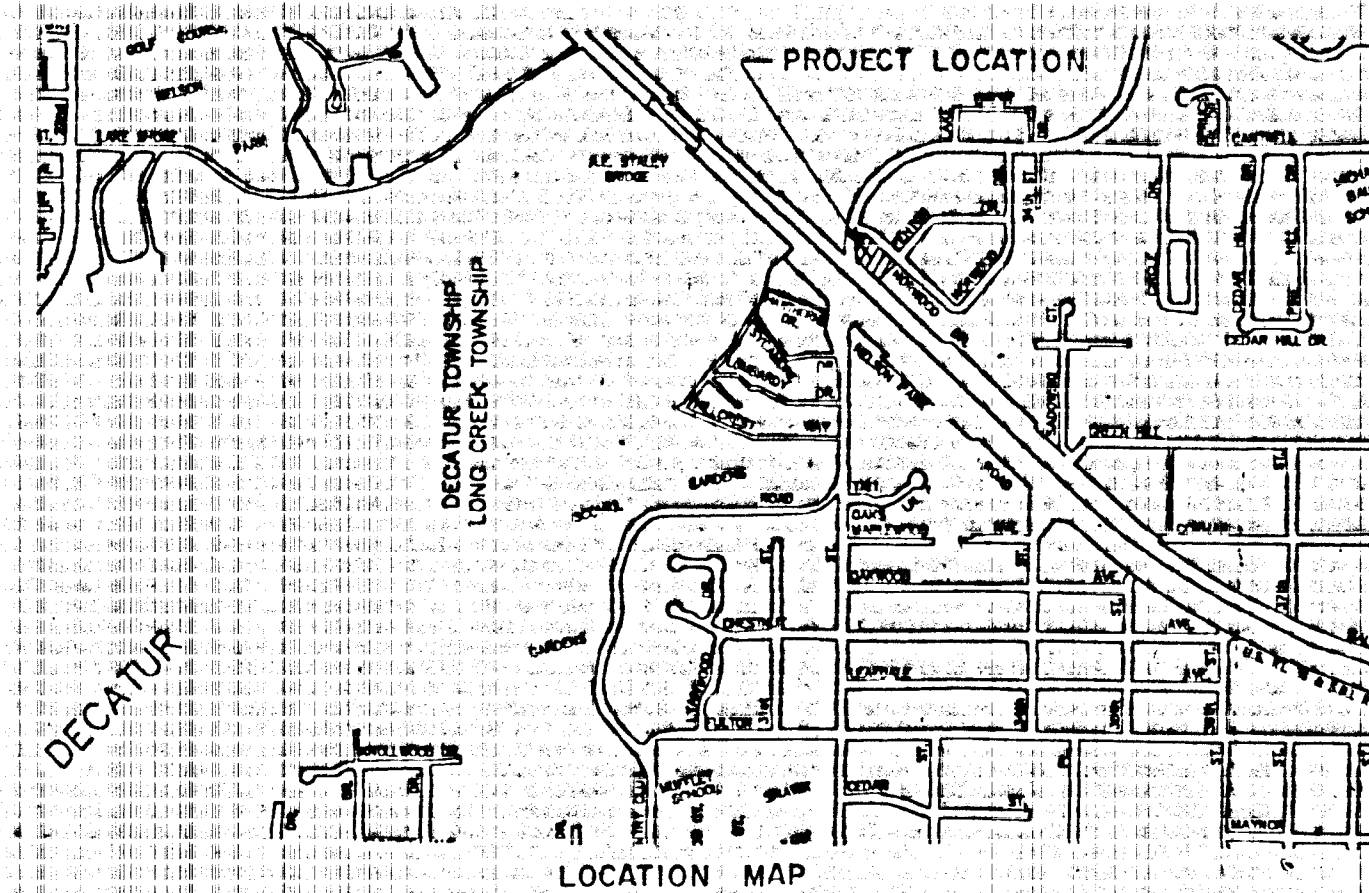


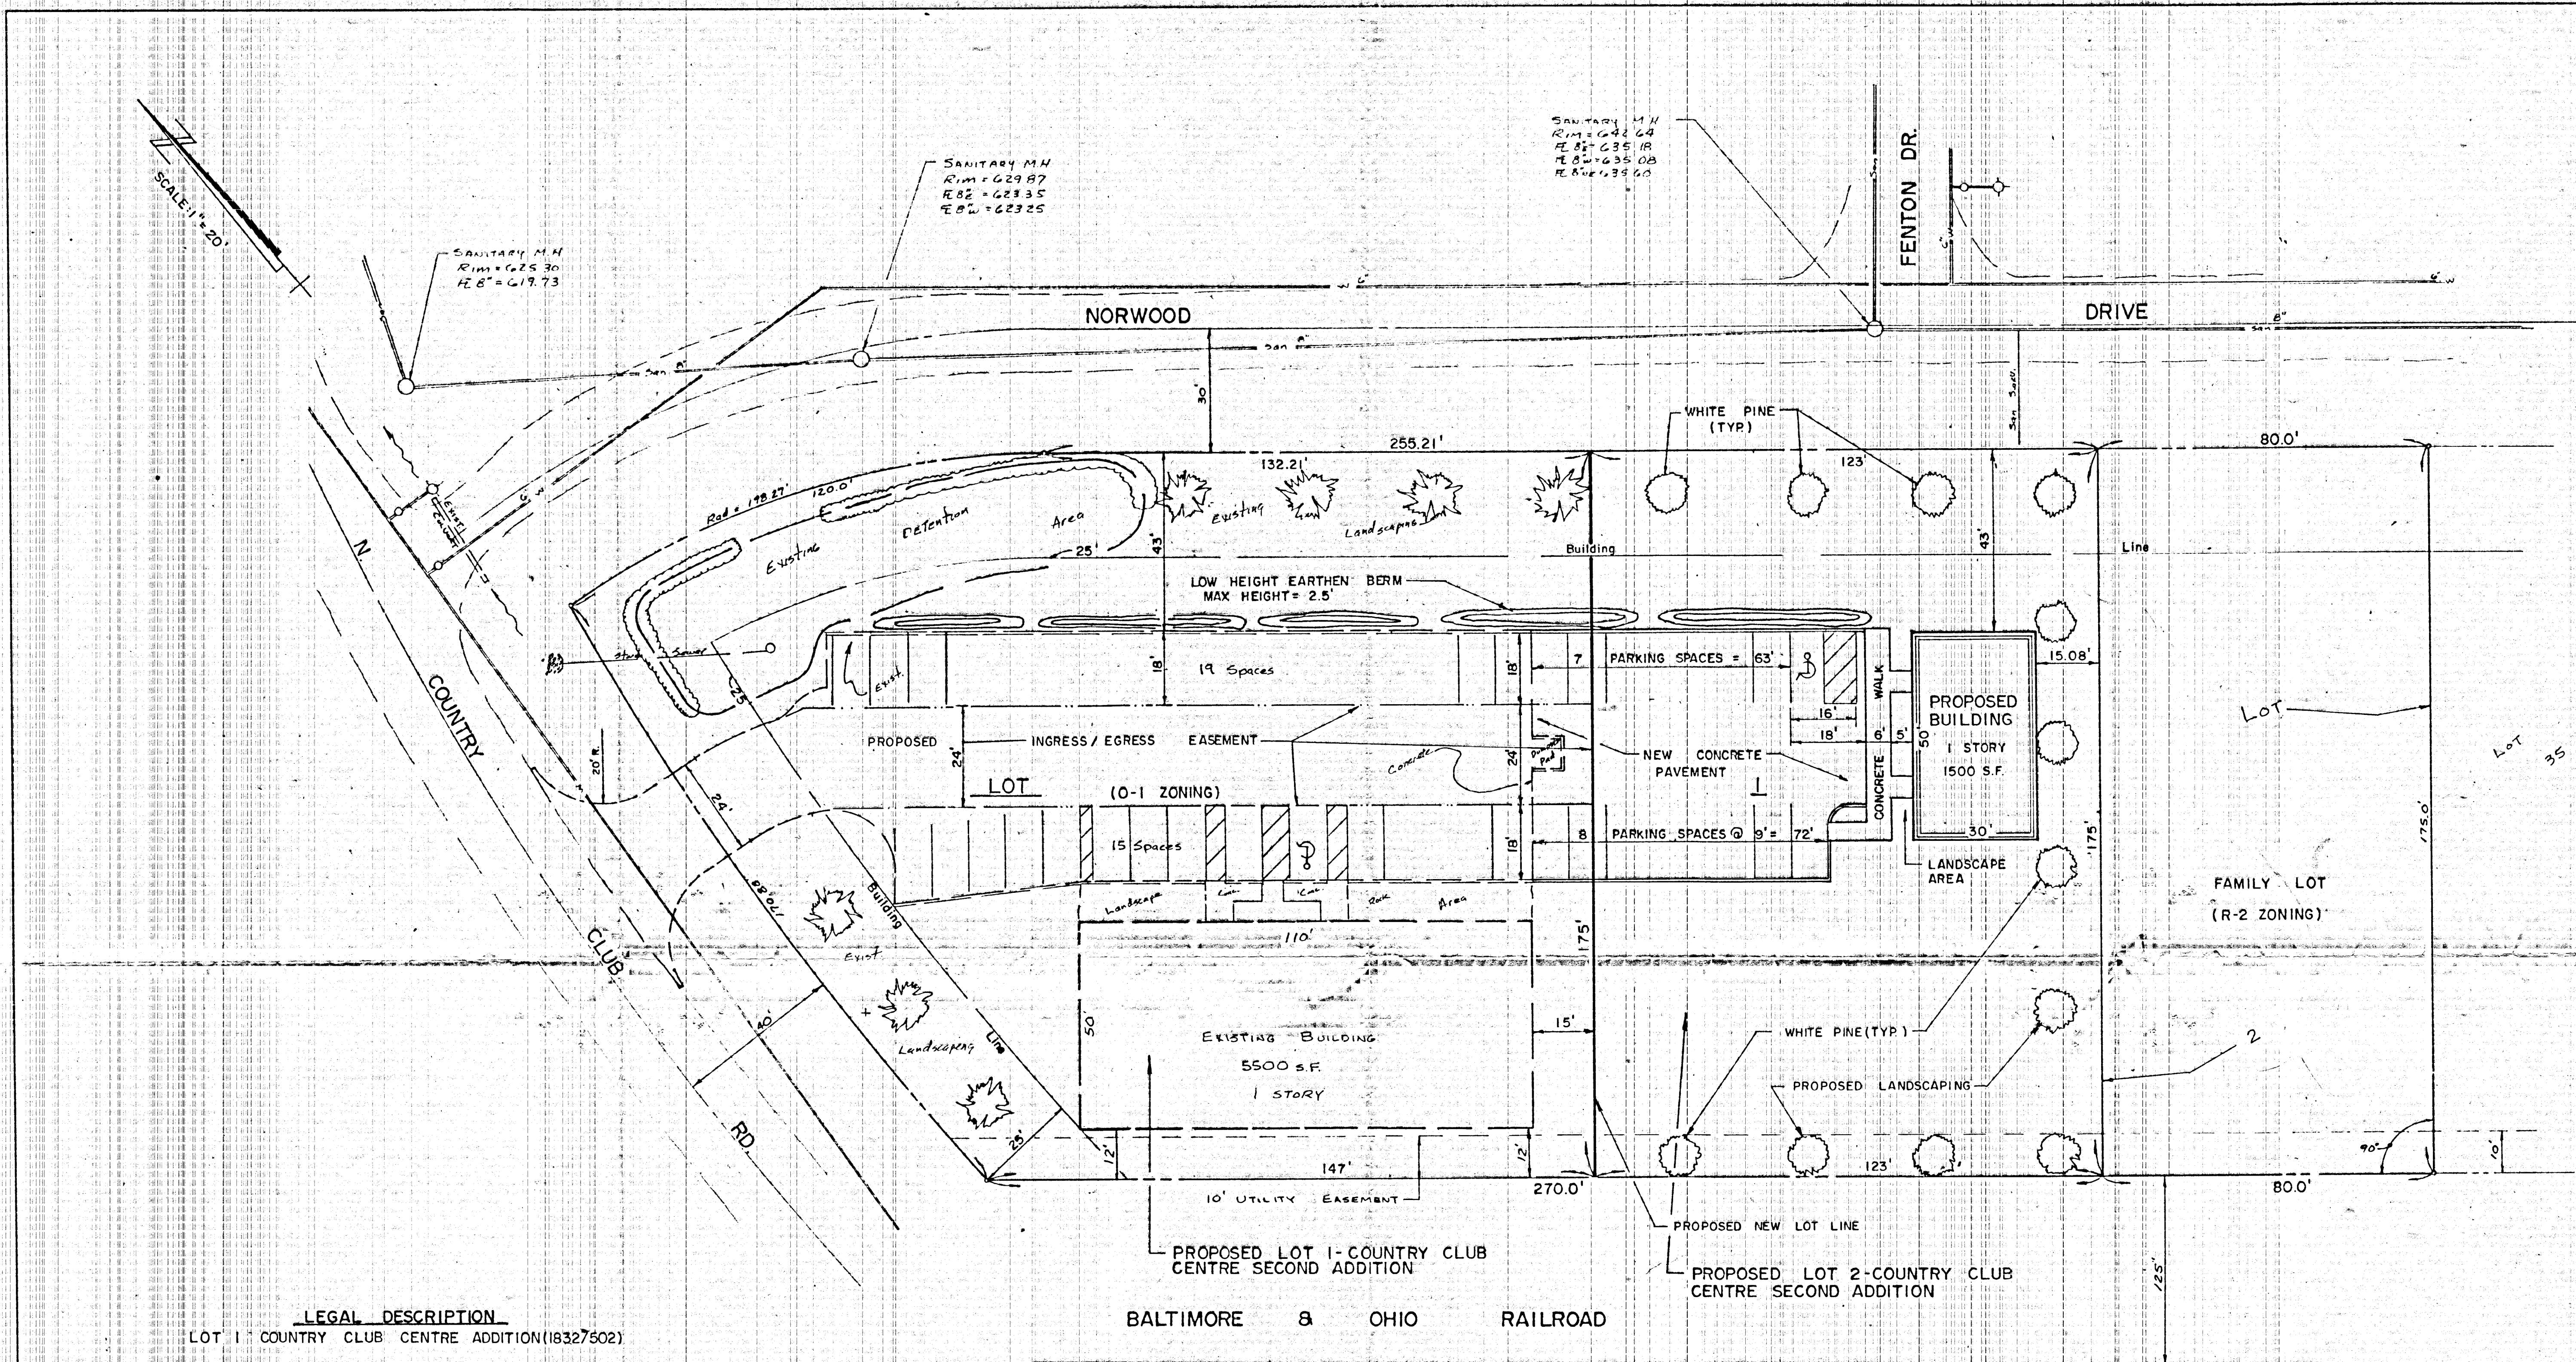

REVISED 0-1 P.U.D.

SITE PLAN

COUNTRY CLUB CENTRE

FWC

phillip w. cochrane • consulting engineer • decatur, illinois
 2602 n. morgan • 62526 • (217) 875-3333 • fax 875-3371

DRAWN BY S.P.M.		REVISIONS		PROJECT NO.
DATE	NO.	DATE	BY	DESCRIPTION
2-09-00	1			
CHECKED BY				FILE NO. FIELD BY NO.
DATE				SHEET NO.
APP'D. BY				
DATE				