

Amica
WIRELESS PHONE SERVICE



MAURER & STUTZ, INC.
ENGINEERS SURVEYORS

PH: (309) 693-7615
FAX: (309) 693-7616

CHECKED BY: ADC

REVISIONS			
NO.	DATE	ISSUE	BY
8			
7			
6			
5			
4			
3			
2			
1			
A			

SITE INFORMATION

SITE NAME
SLIFER

SITE NUMBER
DEC-034.02

SITE ADDRESS
1375 S. MONROE
DECATUR, ILLINOIS 62523

COVER SHEET

SHEET NUMBER	REV.
T 1	A

EXHIBIT "A"

DEC-034.02

[illegible]
MAURER & STUTZ, INC.
 ENGINEERS SURVEYORS

EXPRESS: 11/99 SIGNED: 13.6.99

SIGNED: 13.6.98

STANDARD CIVIL NOTES

1. ALL SITE WORK SHALL BE AS INDICATED ON THE DRAWINGS.
2. THE GENERAL CONTRACTOR AND OR HIS SUBCONTRACTOR SHALL BE RESPONSIBLE FOR OBTAINING ALL PERMITS AND INSPECTIONS WHICH MAY BE REQUIRED FOR THE WORK BY THE ARCHITECT/ENGINEER, THE STATE, COUNTY OR LOCAL GOVERNMENT AUTHORITY.
3. DESIGN REQUIREMENTS FOR THE ANTENNA SUPPORTING STRUCTURE SHALL BE PER BOCA NATIONAL BUILDING CODE/1996, LOCAL BUILDING CODES, AND THE ANSI/TIA-222-E STRUCTURAL STANDARDS FOR STEEL ANTENNA SUPPORTING STRUCTURES. THE BASIC WIND SPEED UTILIZED FOR DESIGN IS 80 MPH PLUS 1/2" ICE.
4. IN THOSE AREAS REQUIRING SURFACE PREPARATION, SITE AREA SHALL BE CLEARED AND GRUBBED. REMOVE UNSUITABLE SOFT OR LOOSE SOILS, ORGANIC MATERIAL AND OR RUBBLE TO FIRM SUBGRADE AS RECOMMENDED BY GEOTECHNICAL REPORT AND DISPOSE OF LEGALLY. THE SUBGRADE SHALL BE COMPACTED AND BROUGHT TO A SMOOTH UNIFORM GRADE PRIOR TO THE CRUSHED STONE APPLICATION. PLACE MIRAFI 500X WEED CONTROL FABRIC ON SUBGRADE FINISH MINIMUM OF 6 INCHES OF GRADE 9 (CA-6) STONE TO FINISH. IF UNANTICIPATED UNSUITABLE SOIL CONDITIONS ARE ENCOUNTERED DURING EXCAVATION, GENERAL CONTRACTOR SHALL NOTIFY GEOTECHNICAL ENGINEER.
5. NO FILL OR EMBANKMENT MATERIAL SHALL BE PLACED ON FROZEN GROUND. FROZEN MATERIALS, SNOW OR ICE SHALL NOT BE PLACED IN ANY FILL OR EMBANKMENT.
6. ANY AREAS ADJACENT TO THE SITE DISTURBED BY THE WORK SHALL BE RETURNED SUBSTANTIALLY TO ORIGINAL CONDITION USING LIKE MATERIAL FOR SURFACE COVERAGE.
7. CONTRACTOR SHALL VERIFY TRUE NORTH AND INFORM CONSTRUCTION MANAGER OF ANY DISCREPANCIES BEFORE STARTING CONSTRUCTION.
8. PCS MINICELL CABINETS FOUNDATION DESIGN IS UNDER SEPARATE CONTRACT BY OTHERS AND IS EXCLUDED FROM THESE DESIGN DRAWINGS. REFER TO OWNER PROVIDED DRAWINGS FOR SPECIFIC DETAILS REGARDING FOUNDATION SYSTEM.
9. TOWER STRUCTURE AND FOUNDATION DESIGN IS UNDER SEPARATE CONTRACT BY OTHERS AND IS EXCLUDED FROM THESE DESIGN DRAWINGS. REFER TO OWNER PROVIDED DRAWINGS FOR SPECIFIC DETAILS REGARDING FOUNDATION SYSTEM.
10. ACCESS ROAD SHALL BE CONSTRUCTED IN ACCORDANCE WITH APPROPRIATE HIGHWAY AUTHORITY.

LEGEND

- IRON PIPE SET
- IRON MONUMENT FOUND
- RAILROAD SPIKE FOUND
- STONE FOUND
- R.O.W. MONUMENT FOUND
- EXISTING UTILITY POLE
- EXISTING UTILITY POLE W/ TRANSFORMER
- EXISTING UTILITY POLE W/ LIGHT
- EXISTING UTILITY POLE W/ LIGHT AND TRANSFORMER
- EXISTING GUY WIRE
- EXISTING TELEPHONE SPLICE BOX
- EXISTING ELECTRIC SPLICE BOX
- EXISTING ROAD SIGN
- EXISTING FIRE HYDRANT
- EXISTING GAS METER
- EXISTING DECIDUOUS TREE
- EXISTING CONIFEROUS TREE
- EXISTING BUILDING FACE
- EXISTING WIRE FENCE
- EXISTING CHAINLINK FENCE
- EXISTING AERIAL ELECTRIC
- EXISTING AERIAL ELECTRIC AND TELEPHONE
- EXISTING AERIAL TELEPHONE
- EXISTING UNDERGROUND TELEPHONE AS LOCATED BY J.U.L.I.E.
- EXISTING UNDERGROUND GAS LINE AS LOCATED BY J.U.L.I.E.
- EXISTING SURFACE CONTOUR LINE
- DEED LINE
- INDICATES INGRESS-EGRESS EASEMENT AS SHOWN ON SLIFER SECOND ADDITION SUBDIVISION PLAT, BK. 1832, PG. 570.

ABBREVIATIONS

- A.F.G. ABOVE FINISHED GRADE
- AWG AMERICAN WIRE GAUGE
- BCW BARE COPPER WIRE
- GPS GEOSTATIONARY POSITIONING SYSTEM
- PCS PERSONAL COMMUNICATION SERVICE
- PPC POWER PROTECTION CABINET
- PRC PRIMARY RADIO CABINET
- RWY RACEWAY
- TYP. TYPICAL
- RGS RIGID GALVANIZED STEEL
- EMT ELECTRICAL METALLIC TUBING, DRAWING
- DWG INTERIOR GROUND RING (HAI O)
- IGR ANTENNA CABLE COVER ASSEMBLY
- ACCA BASE TRANSMISSION SYSTEM
- BTS GENERATOR
- GEN GROWTH CABINET
- GRO RECTIFIER CABINET
- REC BATTERY CABINET
- BAT



LUCENT TECHNOLOGIES



PCS INSTALLATION PROJECT



7615 North Harker Drive
Peoria, Illinois 61615
PH: (309) 693-7615
FAX: (309) 693-7616

PROJECT NO.: 232-98010

DRAWN BY: SPF

CHECKED BY: ADC

REVISIONS

NO.	DATE	ISSUE	BY
1			
2			
3			
4			
5			
6			
7			
8			
9			
10			

SITE INFORMATION

SITE NAME:
SLIFER

SITE NUMBER:
DEC-034.02

SITE ADDRESS:
**1375 S. MONROE
DECATUR, ILLINOIS 62523**

SHEET TITLE

SITE PLAN / SITE DETAIL

SHEET NUMBER

A 1

 
REV.

A


SITE PLAN




SCALE: 1" = 60'



SITE LAYOUT DETAIL

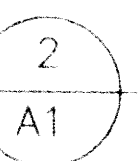


SCALE: 1" = 4'

 


NOTES:


1. IF NECESSARY, CONTRACTOR SHALL GRADE SITE TO ALLOW FOR PROPER DRAINAGE. MINIMUM SLOPE ON SITE IS 1%, MAXIMUM SLOPE IS 3%. CONTRACTOR SHALL ALLOW FOR UNINTERRUPTED OFFSITE FLOW TO CONTINUE IN NATURAL PATH. REPORT CONFLICTS TO CONSTRUCTION MANAGER AT ONCE.
2. CONTRACTOR SHALL VERIFY LOCATION OF STORM SEWER, IF ANY, AND RELOCATE AS NECESSARY.

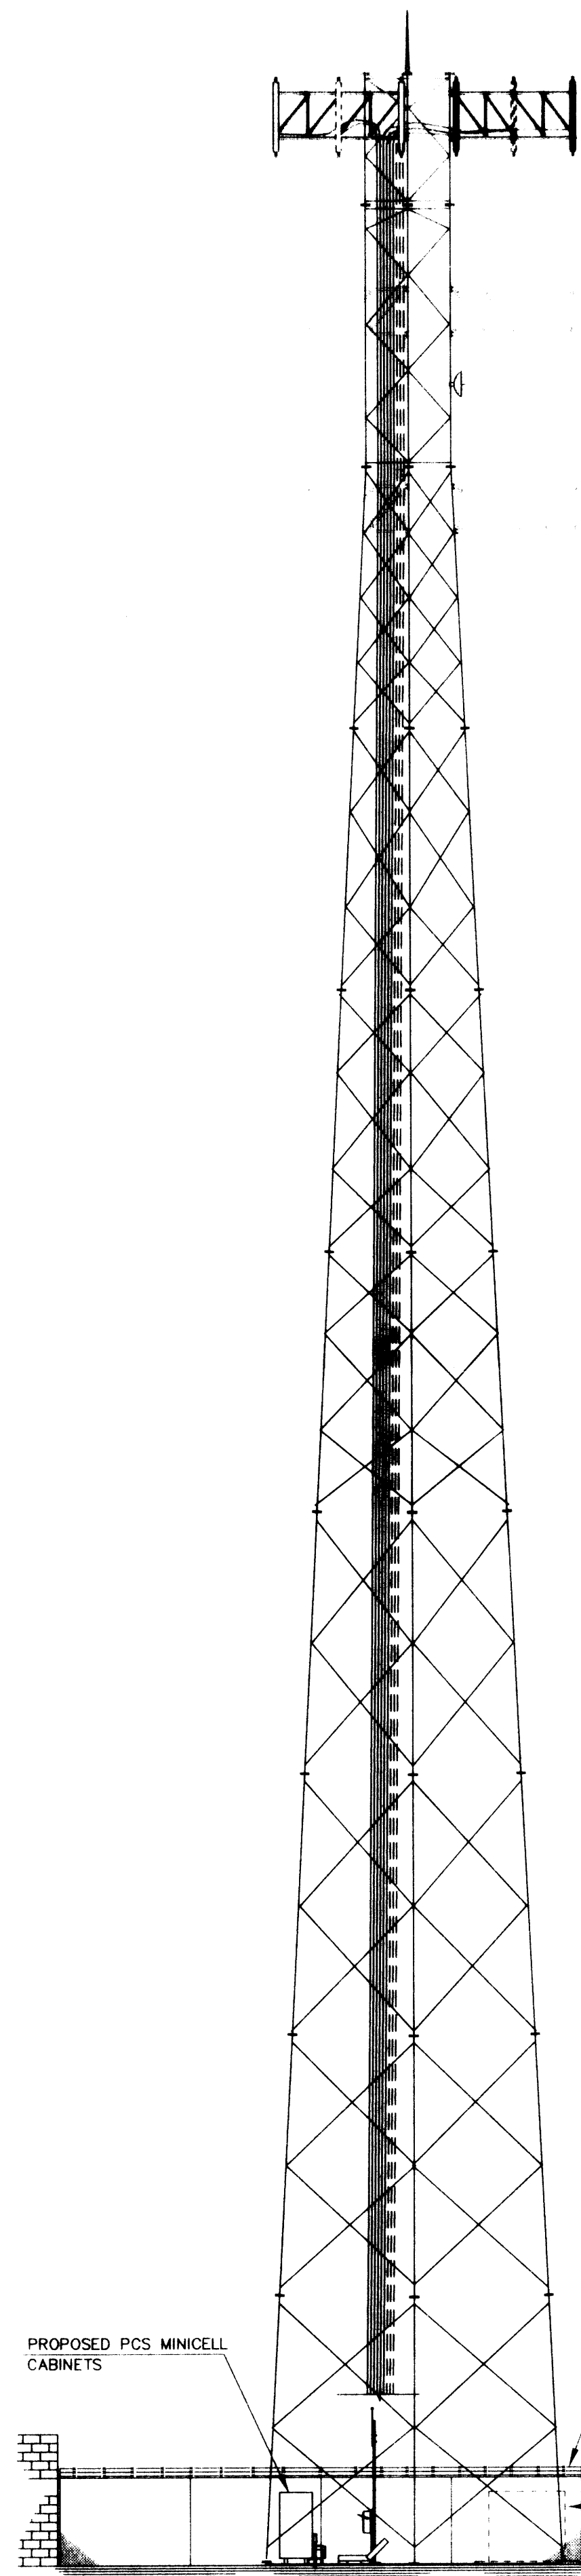


1 WEST ELEVATION
A2

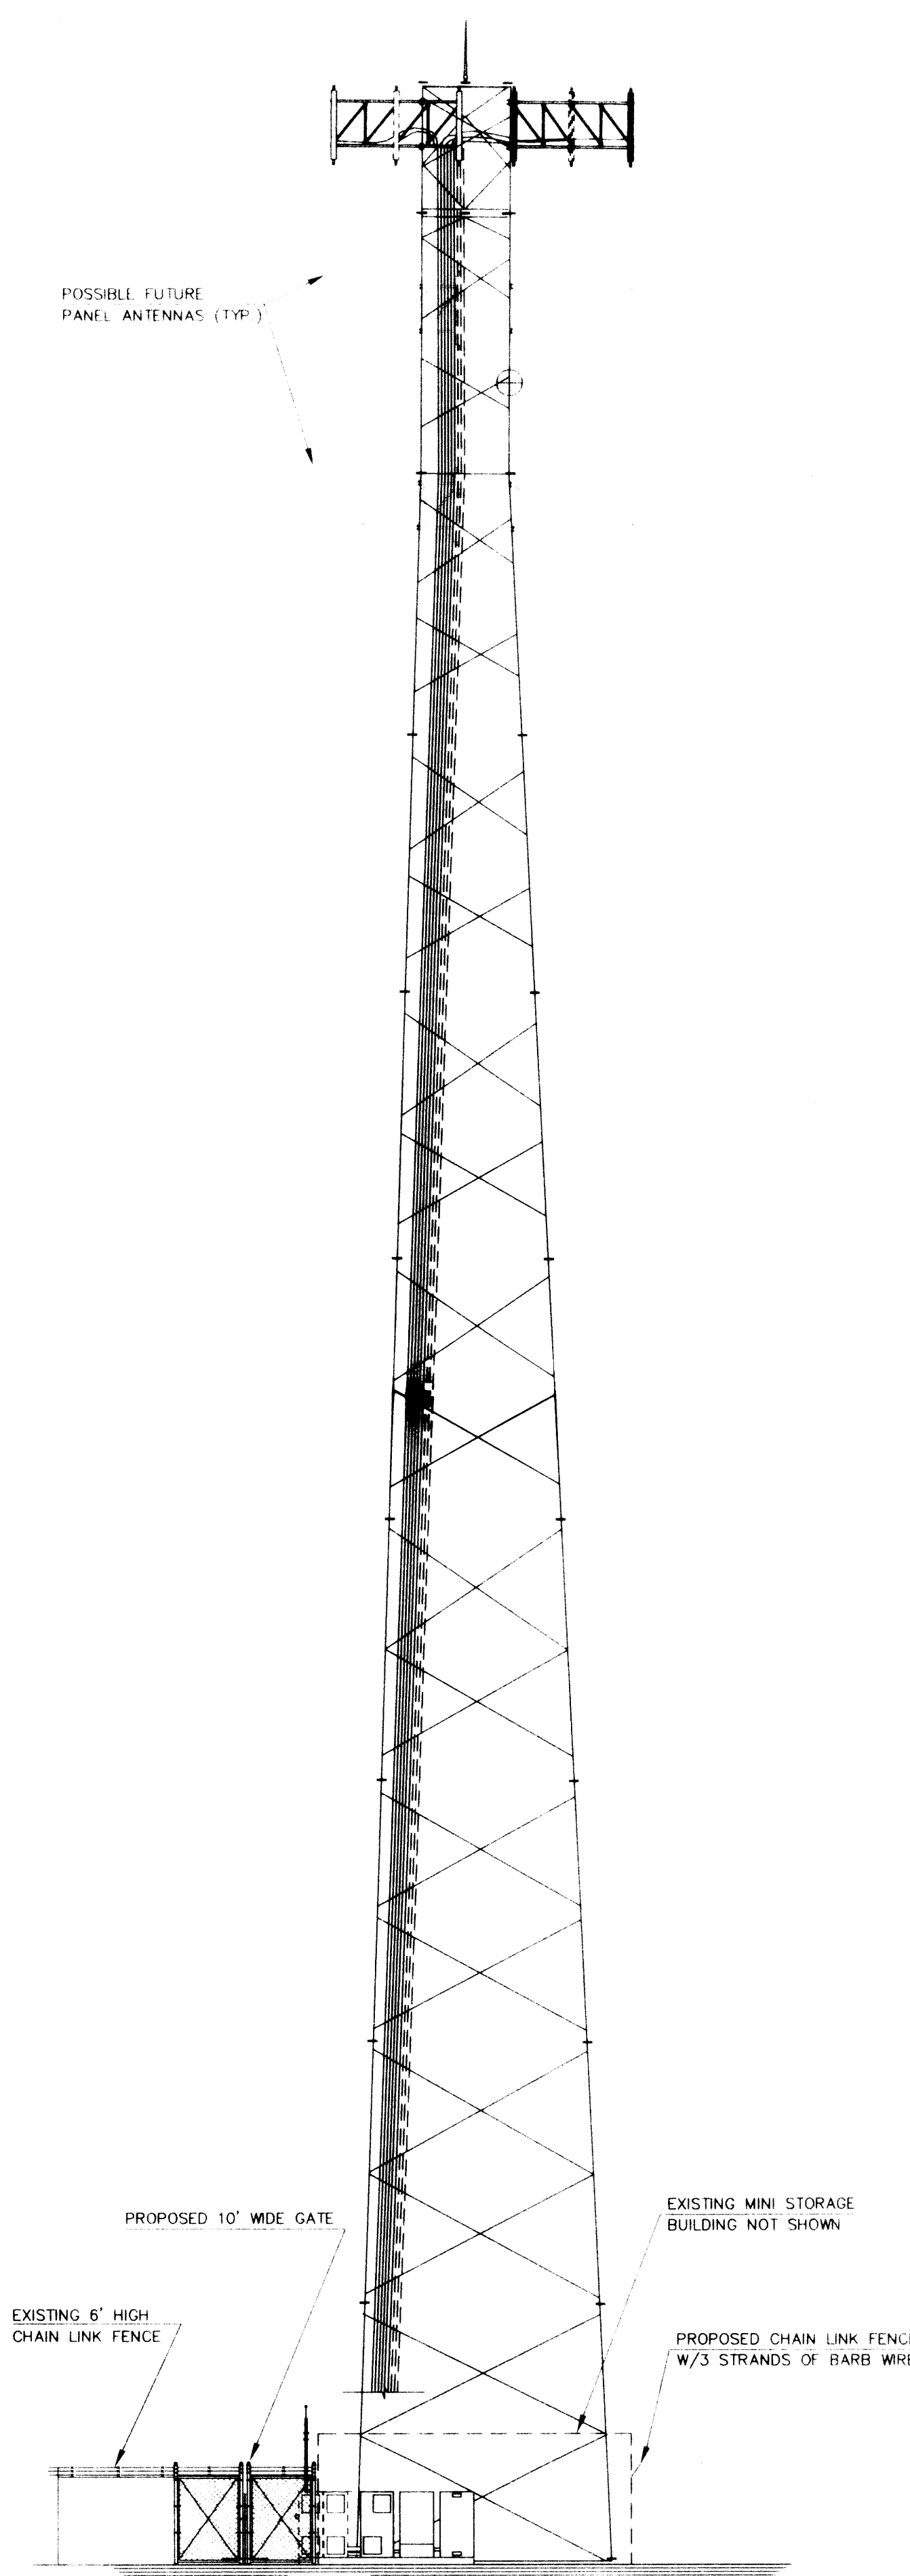

2 NORTH ELEVATION
A2

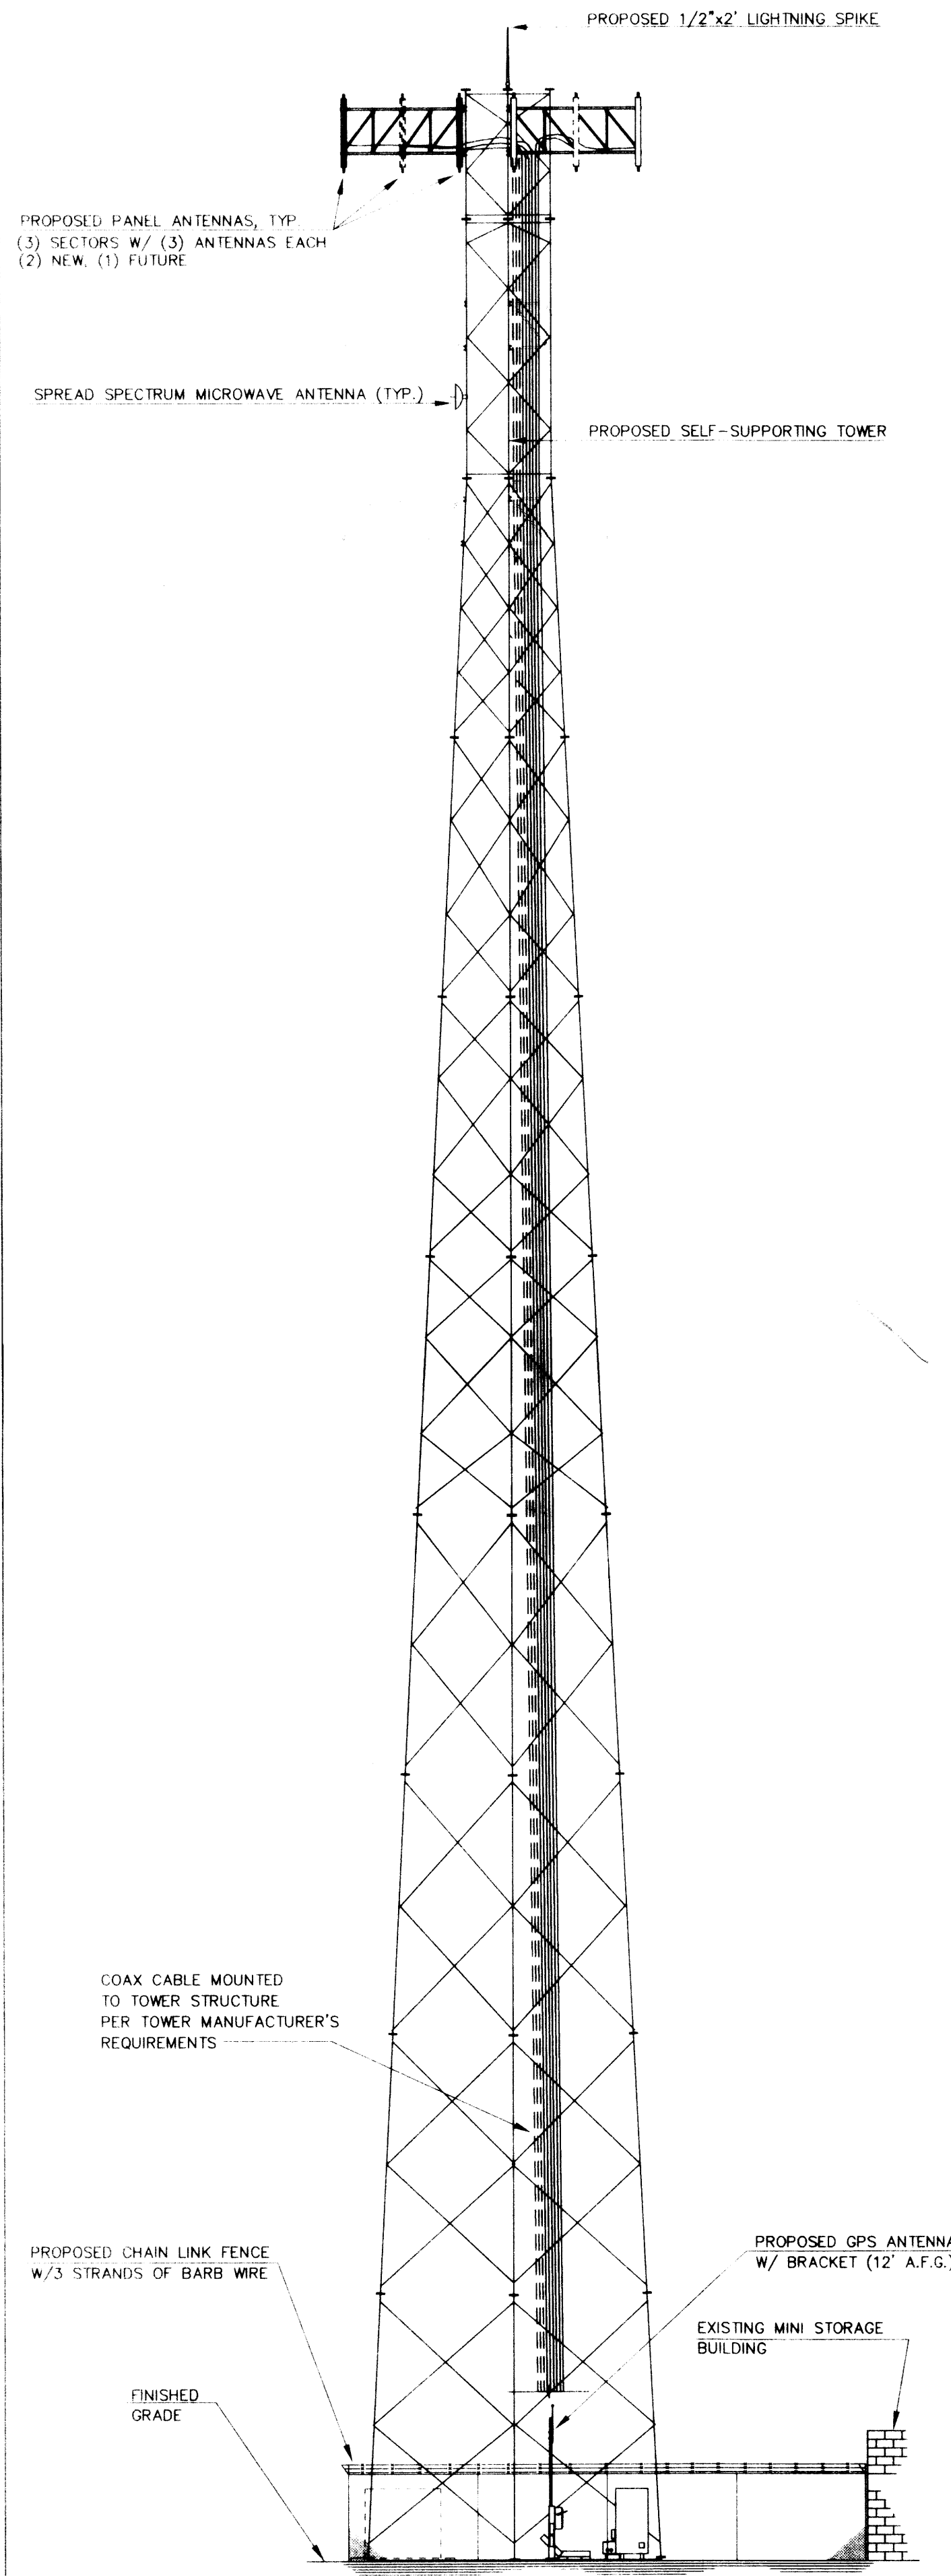

3 EAST ELEVATION
A2

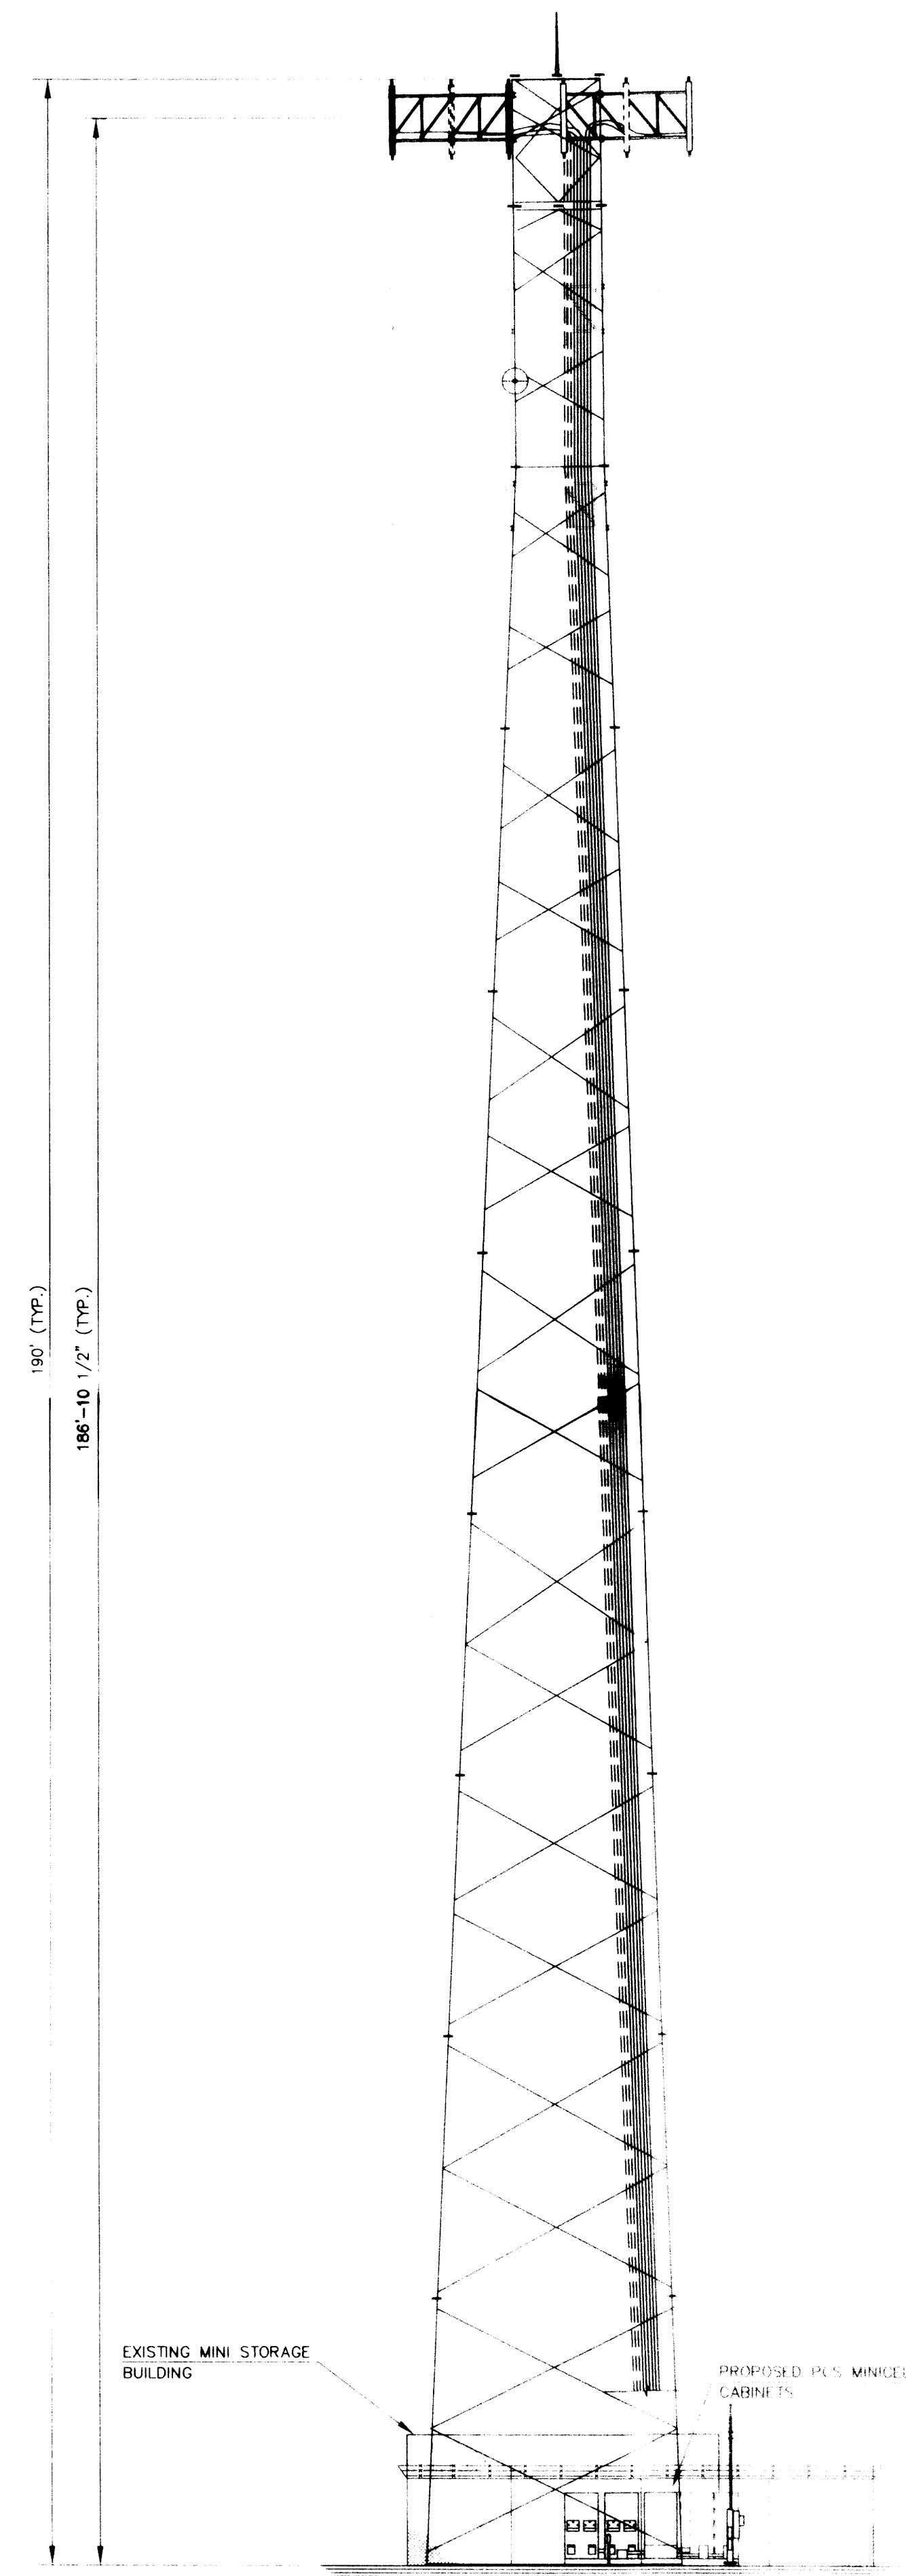

4 SOUTH ELEVATION
A2

0 5 10 20
GRAPHIC SCALE: 1" = 10'

LUC-2-A2

Amica
WIRELESS PHONE SERVICE

LUCENT TECHNOLOGIES



PCS INSTALLATION PROJECT

MAURER & STUTZ, INC.
ENGINEERS SURVEYORS

7615 North Harker Drive
Peoria, Illinois 61615
PH: (309) 693-7615
FAX: (309) 693-7616

PROJECT NO.: 232-98010

DRAWN BY: BSB

CHECKED BY: ADC

REVISIONS			
NO.	DATE	ISSUE	BY
8			
7			
6			
5			
4			
3			
2			
1			
A			

SITE INFORMATION

SITE NAME:
SLIFER
SITE NUMBER:
DEC-034.02
SITE ADDRESS:
**1375 S. MONROE
DECATUR, ILLINOIS 62523**

SHEET TITLE

ELEVATIONS

SHEET NUMBER
A 2
REV
A